



1:32
AIR MASTER SERIES
AM-32-086


P-38 LIGHTNING
 EARLY ARMAMENT (.50 CAL BROWNING'S
 WITH DRILLED COOLING JACKETS
 & EARLY AND LATE 20MM CANNON TIPS)
 P-38 LIGHTNING - UZBROJENIE TYP Wczesny

SET INCLUDES
 ZESTAW ZAWIERA





MOUNTING PLACE (1:32 SCALE)
 MIEJSCE ZAMOCOWANIA (SKALA 1:32)

USE MOUNTING TUBES
 FOR TRUMPETER KIT

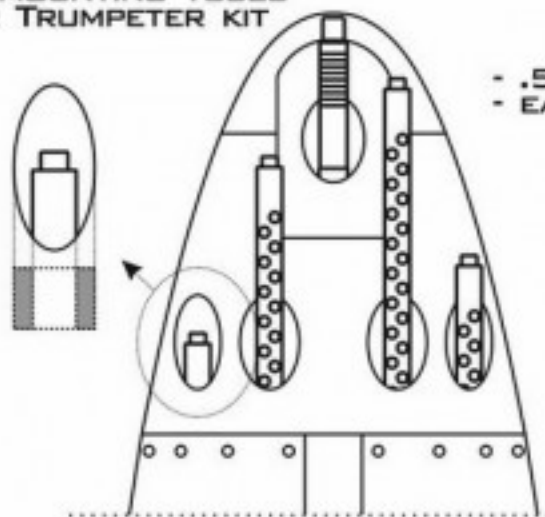

MOST COMMON WEAPON CONFIGURATION
 USED ON EARLY P-38 VERSIONS:

- .50 CAL BROWNING'S WITH DRILLED COOLING JACKETS
- EARLY TYPE OF 20MM CANNON MUZZLE

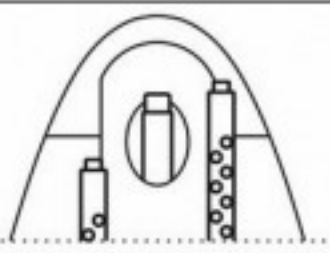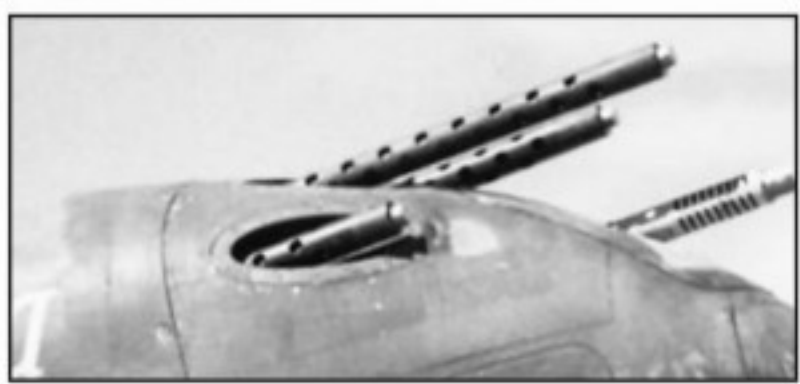

SOME PARTICULAR EXAMPLES FROM P-38 H, J AND L
 SERIES CARRIED FOLLOWING WEAPON CONFIGURATION:

- .50 CAL BROWNING'S WITH DRILLED COOLING JACKETS
- LATE TYPE OF 20MM CANNON MUZZLE



OTHER P-38 MASTER SETS:

- AM-32-087 - P-38 LATE ARMAMENT (.50 CAL BROWNING'S WITH COVERED COOLING JACKETS & LATE 20MM CANNON TIPS)
- AM-32-088 - P-38M .50 CAL BROWNING'S AND 20MM CANNON TIPS WITH FLASH HIDERS



WWW.MASTER-MODEL.PL
 ©COPYRIGHT 2015, MASTER - PIOTR CZERKASOW
 DESIGNED AND PRODUCED IN POLAND