



1:32
AIR MASTER SERIES
AM-32-087


P-38 LIGHTNING
 LATE ARMAMENT (.50 CAL BROWNING'S
 WITH COVERED COOLING JACKETS
 & LATE 20MM CANNON TIP)
 P-38 LIGHTNING - UZBROJENIE TYP PÓŹNY

SET INCLUDES
 ZESTAW ZAWIERA



MOUNTING PLACE (1:32 SCALE)
 MIEJSCE ZAMOCOWANIA (SKALA 1:32)

USE MOUNTING TUBES
 FOR TRUMPETER KIT

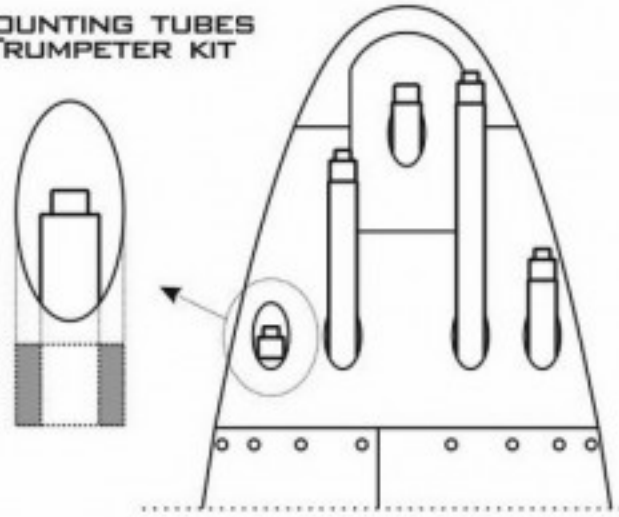

NOTICE: MANY EXAMPLES OF P-38 LATE VERSION WERE ARMED WITH
 .50CAL BROWNING'S WITH DRILLED COOLING JACKET (SEE MASTER SET AM-32-086)

OTHER P-38 MASTER SETS:

AM-32-086 - P-38 EARLY ARMAMENT (.50 CAL BROWNING WITH DRILLED
 COOLING JACKETS & EARLY AND LATE 20MM CANNON TIPS)

AM-32-088 - P-38M .50 CAL BROWNING'S AND 20MM CANNON TIPS
 WITH FLASH HIDERS



WWW.MASTER-MODEL.PL
 ©COPYRIGHT 2015, MASTER - PIOTR CZERKASOW
 DESIGNED AND PRODUCED IN POLAND