



1:32
AIR MASTER SERIES
AM-32-088

P-38M LIGHTNING

.50 CAL BROWNING
& 20MM CANNON TIPS WITH FLASH HIDERS

P-38M LIGHTNING - LUFY UZBROJENIA


SET INCLUDES
ZESTAW ZAWIERA



MOUNTING PLACE (1:32 SCALE)

MIEJSCE ZAMOCOWANIA (SKALA 1:32)

USE MOUNTING TUBES
 FOR TRUMPETER KIT

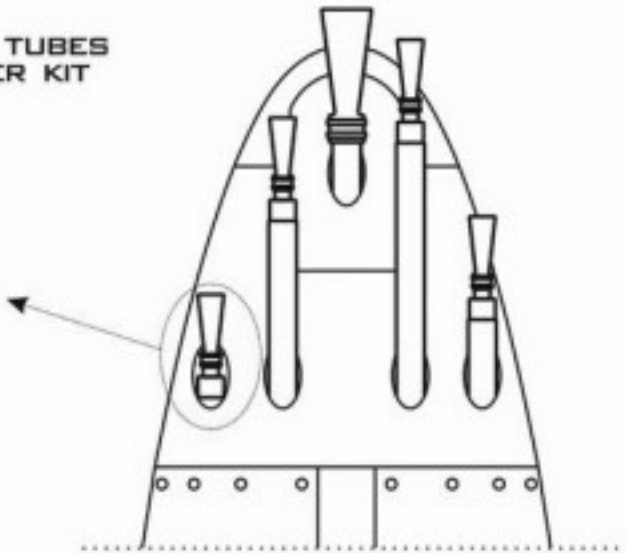

OTHER P-38 MASTER SETS:

AM-32-086 - P-38 EARLY ARMAMENT (.50 CAL BROWNING WITH DRILLED COOLING JACKETS & EARLY AND LATE 20MM CANNON TIPS)

AM-32-087 - P-38 LATE ARMAMENT (.50 CAL BROWNING WITH COVERED COOLING JACKETS & LATE 20MM CANNON TIPS)



WWW.MASTER-MODEL.PL
 ©COPYRIGHT 2015, MASTER - PIOTR CZERKASOW
 DESIGNED AND PRODUCED IN POLAND